


PUMP BACKWASH LINES TERMINATE WITH 6" AIR GAP OVER STANDPIPES (TYPICAL)

12" BACKWASH STANDPIPE DISCHARGE PIPES TO BACKWASH HOLDING TANK

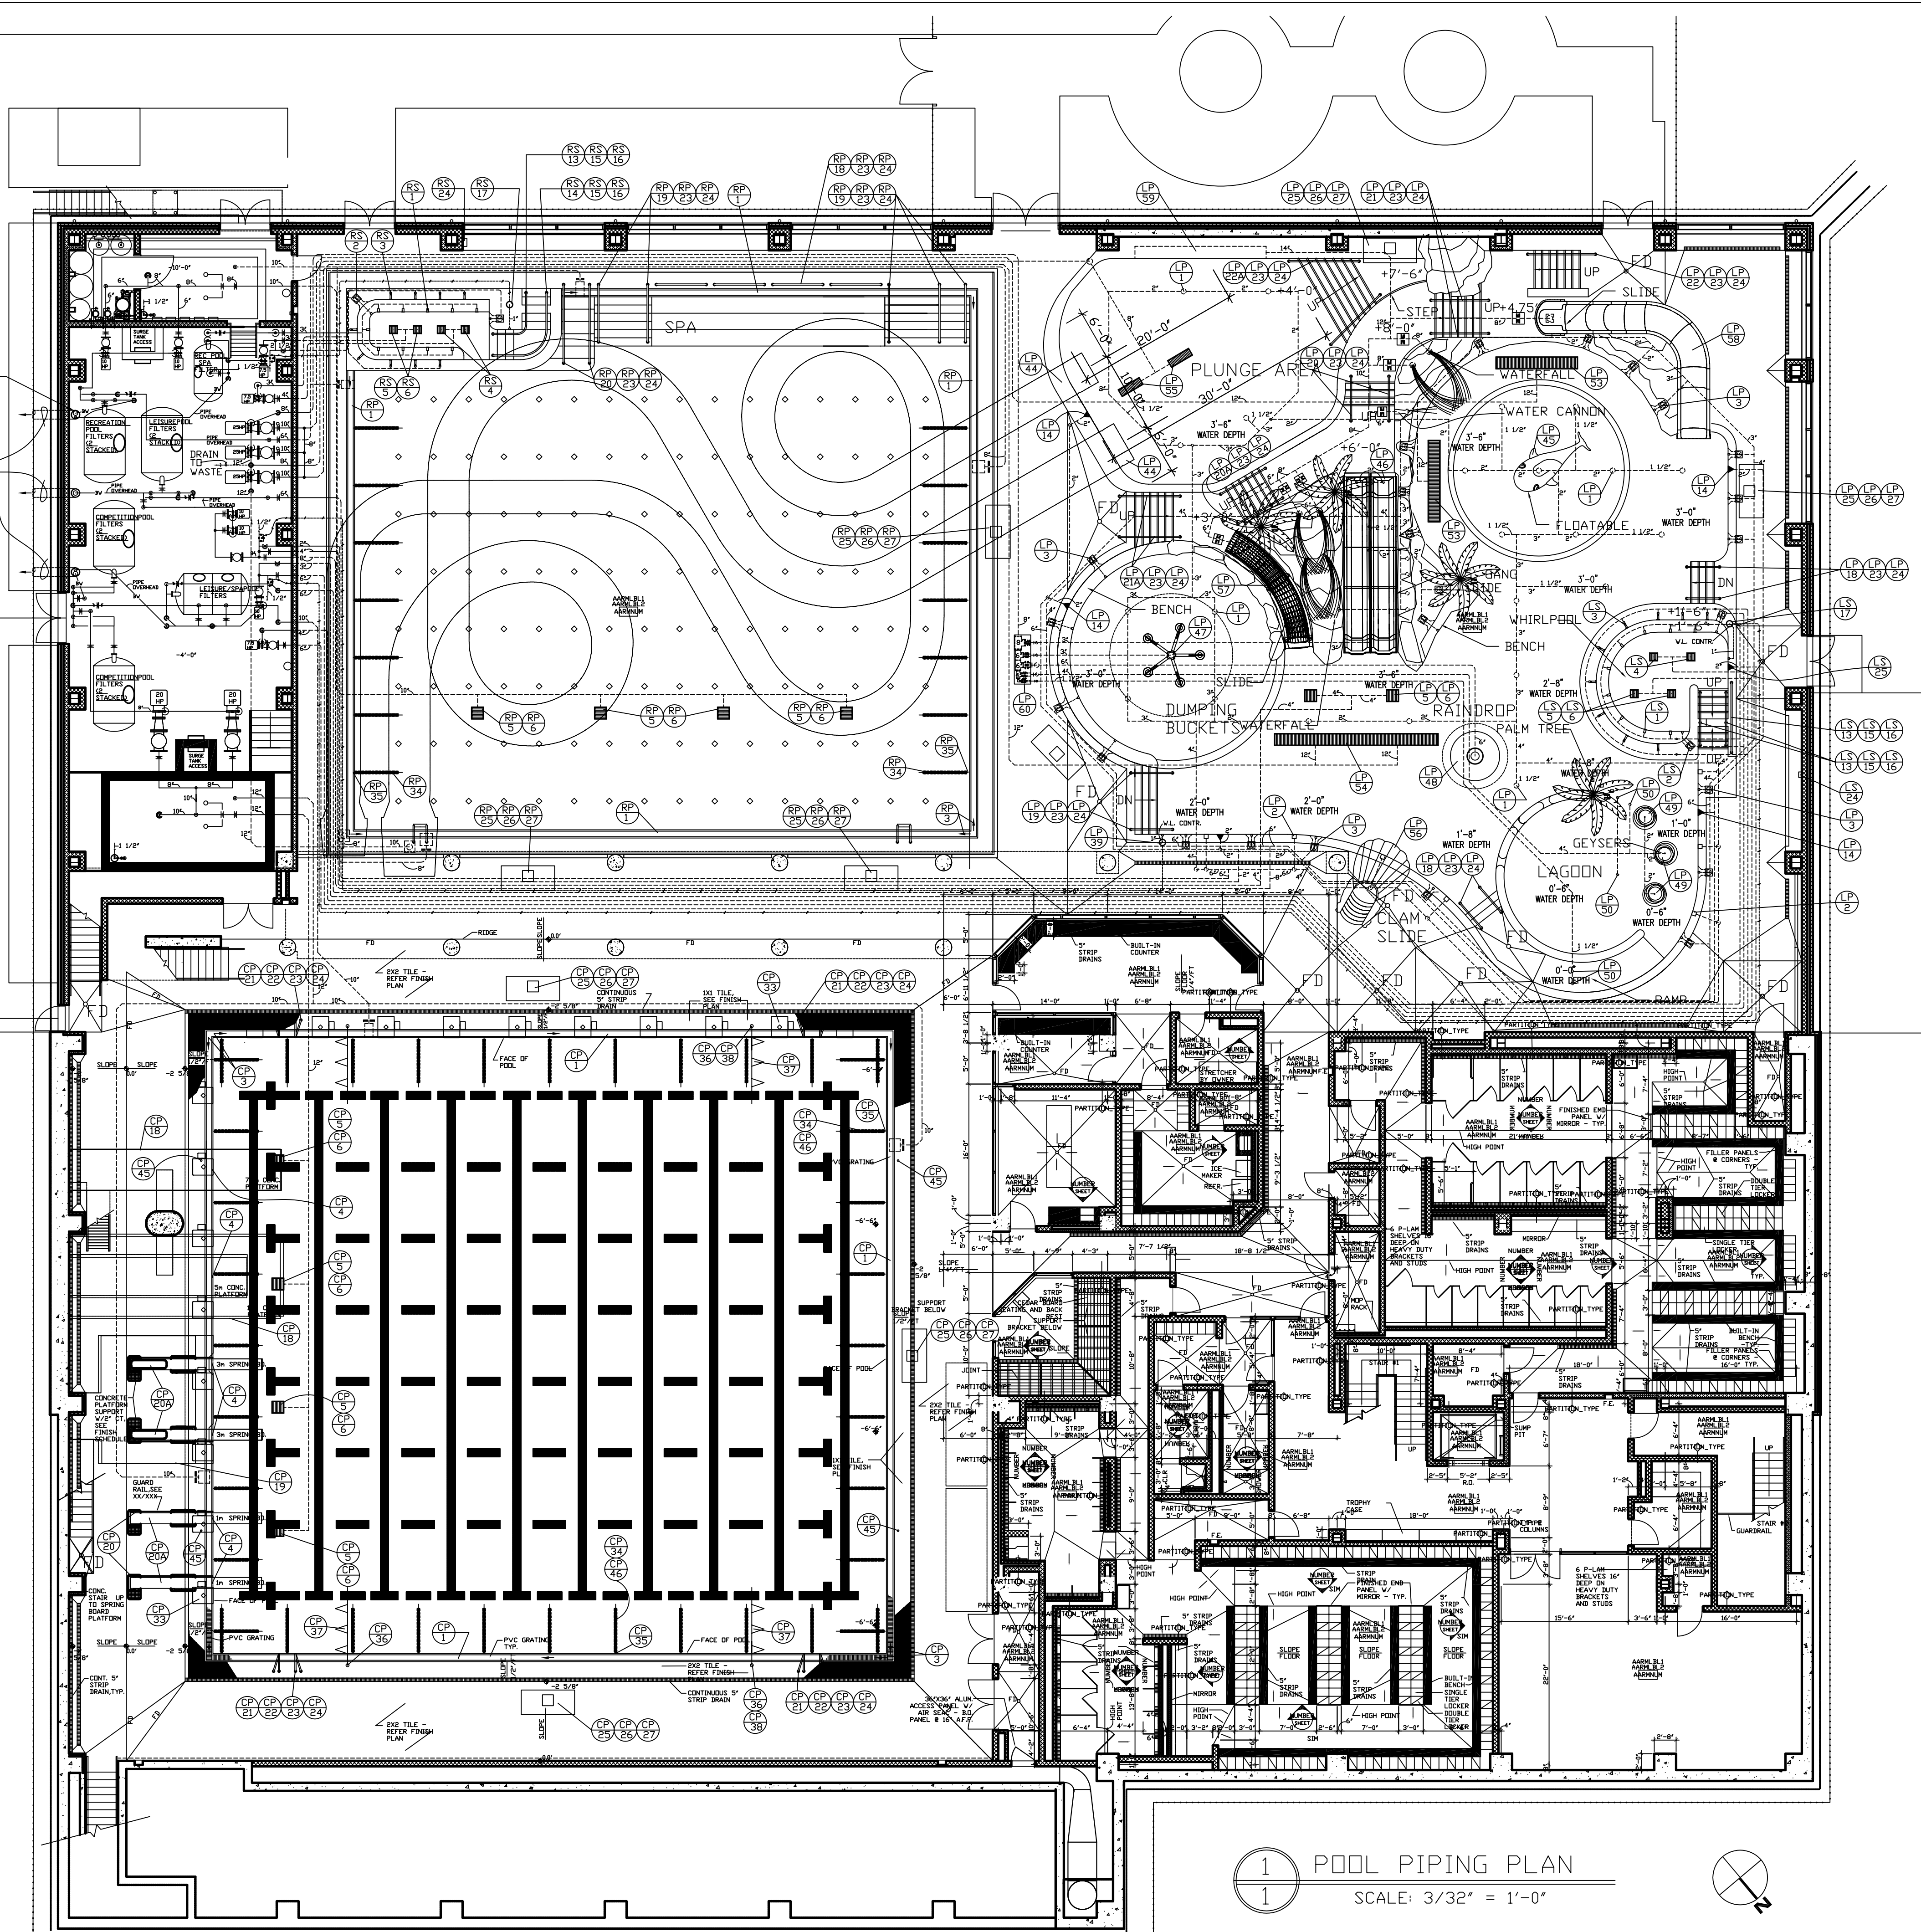


1 POOL PIPING PLAN  
 1 SCALE: 3/32" = 1'-0"

⊖ DENOTES EQUIPMENT LIST NUMBER ON DRAWING PL-3235-2.



LISTED FILTERS  
 CATALOG NO. 6728-H-8-1C-SS  
 CATALOG NO. 6724-H-6-2C-SS  
 CATALOG NO. 6728-H-7-2C-SS

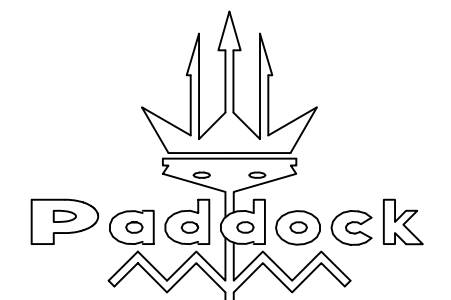

GERMANTOWN INDOOR SWIM CENTER  
 MONTGOMERY COUNTY, MARYLAND

POOL PIPING PLAN

PADDOCK POOL EQUIPMENT CO. INC.

DRAWN BY M.J.G.  
 DATE 4-28-03  
 REV. 5-15-03  
 DRAWING NO. PL-3235-1

ROCK HILL, S.C. 29730